



D.S. PARROTT MIDDLE SCHOOL

19220 YOUTH DRIVE
BROOKSVILLE, FLORIDA 34601

ROOF AND SOFFIT REPLACEMENT 100% CONSTRUCTION DOCUMENTS

MARCH 29, 2024



**HERNANDO
SCHOOL DISTRICT**

Learn it. Love it. Live it.

919 NORTH BROAD STREET
BROOKSVILLE, FLORIDA 34604

BOARD MEMBERS:

DISTRICT #1: MARK JOHNSON

DISTRICT #2: LINDA PRESCOTT (CHAIRPERSON)



DISTRICT #3: SHANNON RODRIGUEZ

DISTRICT #4: GUS GUADAGNINO

DISTRICT #5: SUSAN DUVAL (VICE CHAIRPERSON)

SUPERINTENDENT:

JOHN STRATTON

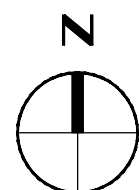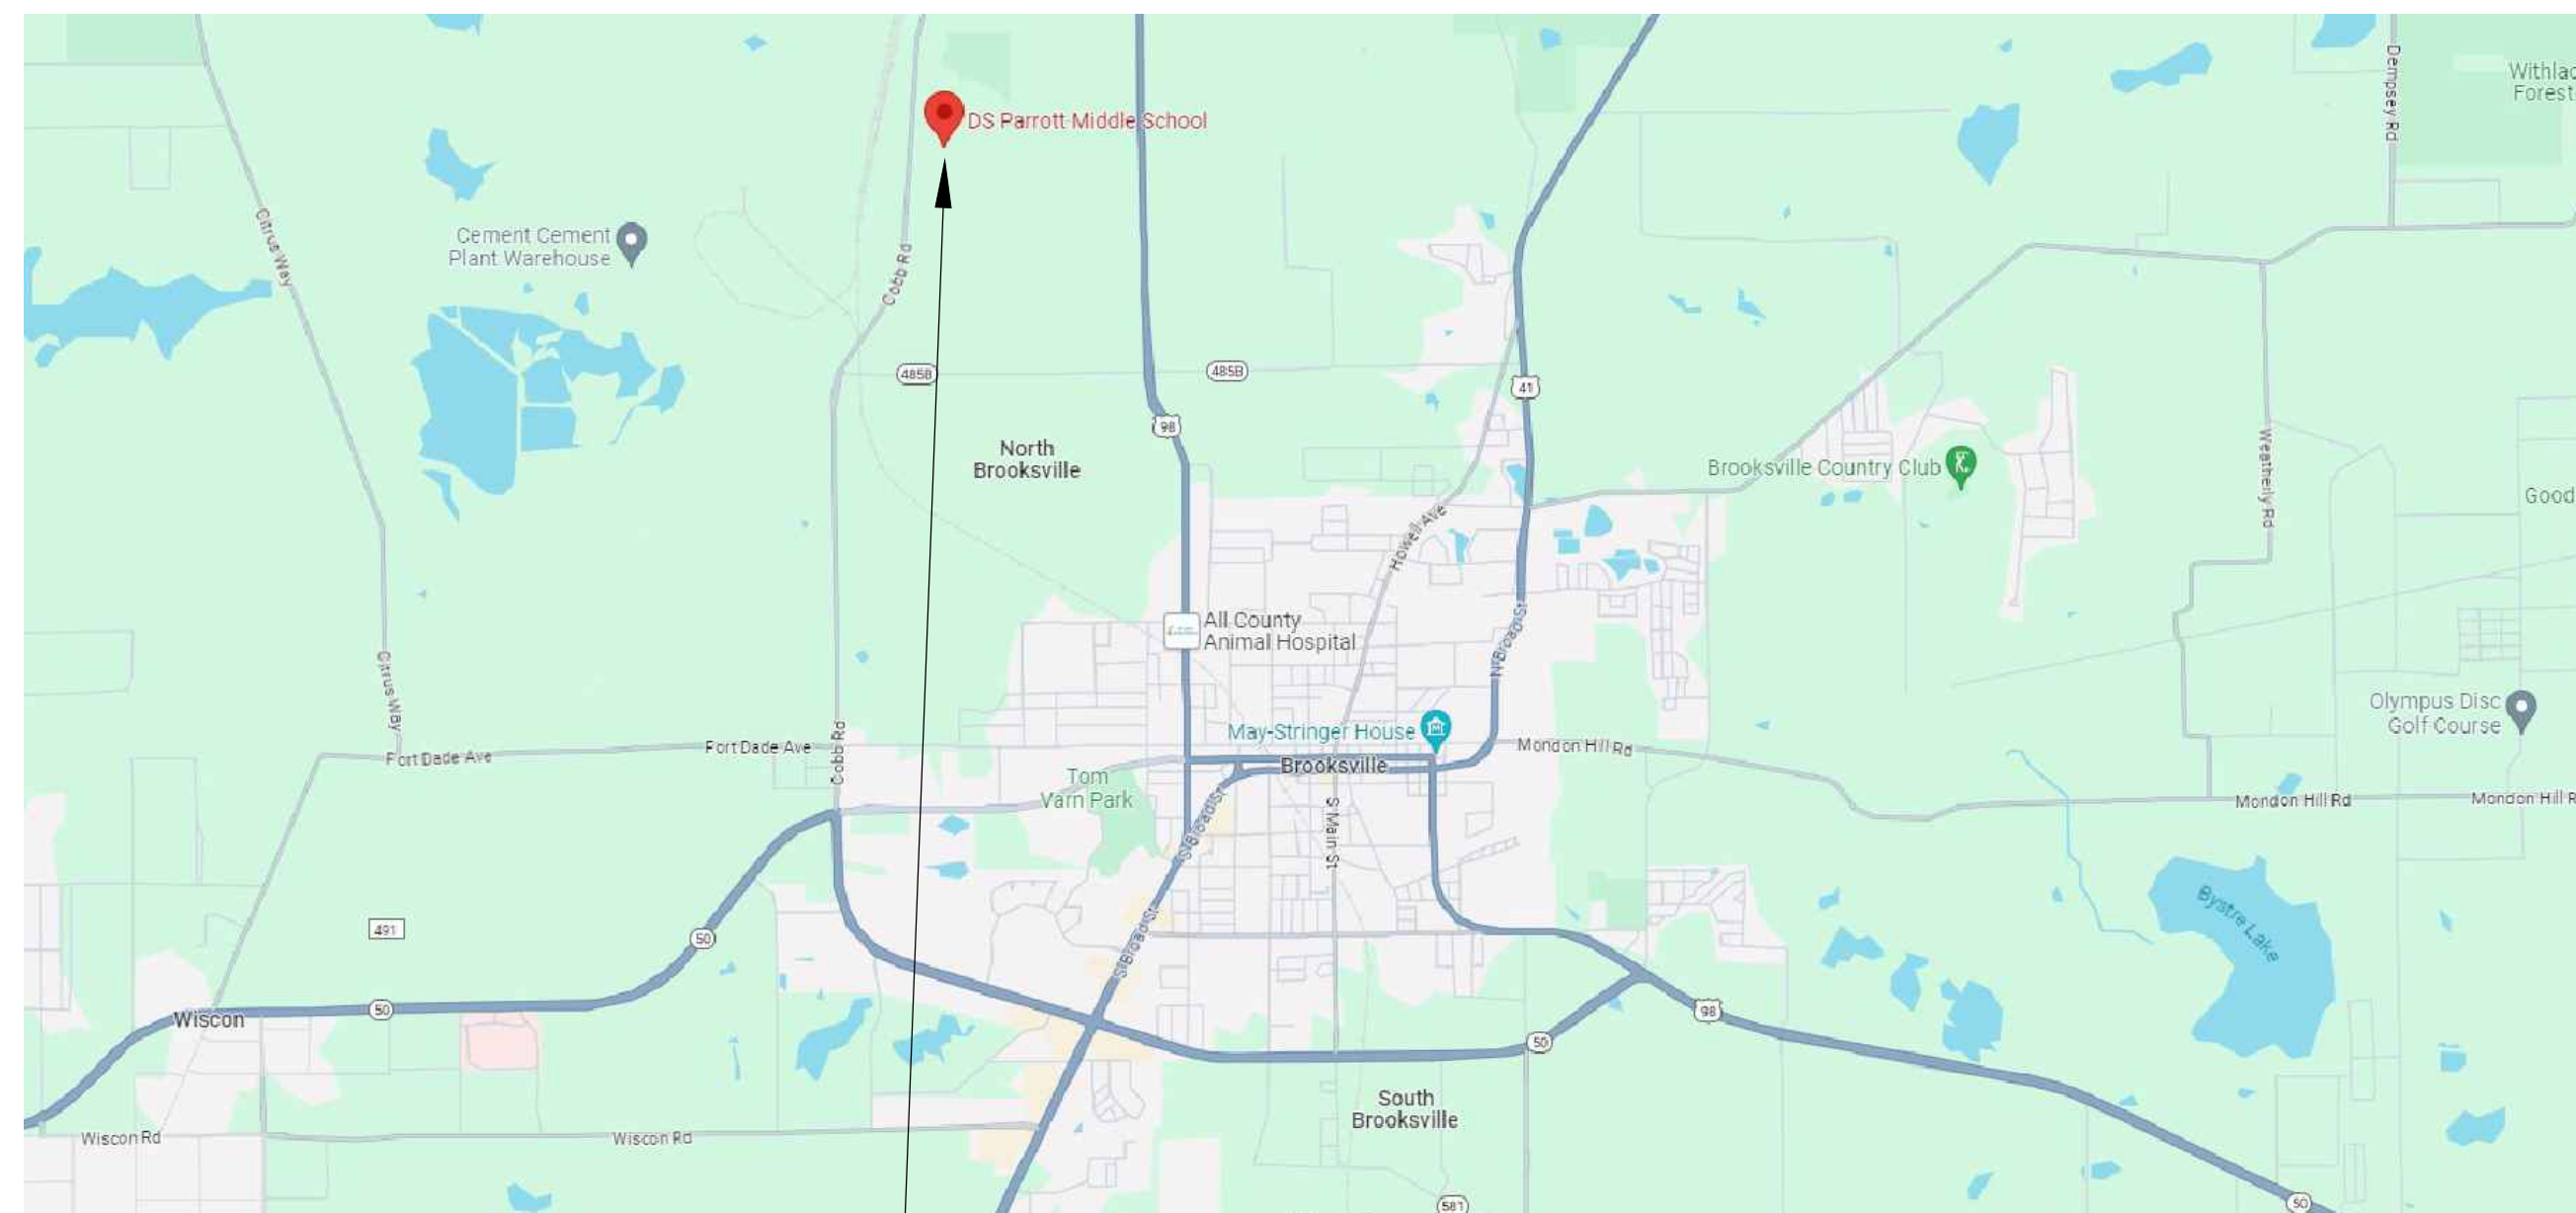

PROJECT LOCATION

PROJECT CONSULTANTS



DYNAMIC ENGINEERING
DESIGN & INSPECTION
STRUCTURAL ENGINEER



PHOENIX ENGINEERING GROUP
ELECTRICAL ENGINEER

EXHIBIT B

SHEET INDEX	
SHEET NUMBER	SHEET TITLE
A0.0	COVER SHEET
A1.1	NOTES AND SPECIFICATIONS
A1.2	NOTES AND SPECIFICATIONS
A2.1	AERIAL PHOTOGRAPH OF SITE AND STAGING PLAN
A2.2	PHOTOGRAPHS OF EXISTING CONDITIONS
A2.3	PHOTOGRAPHS OF EXISTING CONDITIONS
A2.4	PHOTOGRAPHS OF EXISTING CONDITIONS
A2.5	PHOTOGRAPHS OF EXISTING CONDITIONS
A2.6	PHOTOGRAPHS OF EXISTING CONDITIONS
A2.7	PHOTOGRAPHS OF EXISTING CONDITIONS
A2.8	PHOTOGRAPHS OF EXISTING CONDITIONS
A3.1	OVERALL ROOF DIMENSION PLAN
A4.1	EXISTING AND DEMOLITION CONSTRUCTION ROOF PLAN
A4.2	EXISTING AND DEMOLITION CONSTRUCTION ROOF PLAN
A4.3	EXISTING AND DEMOLITION CONSTRUCTION ROOF PLAN
A4.4	EXISTING AND DEMOLITION CONSTRUCTION ROOF PLAN
A5.1	NEW CONSTRUCTION ROOF PLAN
A5.2	NEW CONSTRUCTION ROOF PLAN
A5.3	NEW CONSTRUCTION ROOF PLAN
A5.4	NEW CONSTRUCTION ROOF PLAN
A6.1	ROOF DETAILS
A6.2	ROOF DETAILS
A6.3	ROOF DETAILS
A6.4	ROOF DETAILS
A6.5	ROOF DETAILS
A6.6	ROOF DETAILS
A6.7	ROOF DETAILS
A6.8	ROOF DETAILS
A6.9	ROOF DETAILS
S-1.01	WIND ZONE PLAN BUILDING 01
S-1.02	WIND ZONE PLAN BUILDING 02, 02A & 03
E1	ELECTRICAL LEAD IN SHEET
E2	LIGHTNING PROTECTION - SITE PLAN
E3	LIGHTNING PROTECTION - MAIN BUILDING - WEST
E4	LIGHTNING PROTECTION - MAIN BUILDING - EAST
E5	LIGHTNING PROTECTION - CAFETERIA
E6	LIGHTNING PROTECTION - GYM
E7	ELECTRICAL DETAILS

D.S. PARROTT MIDDLE SCHOOL
ROOF AND SOFFIT REPLACEMENT
100% CONSTRUCTION DOCUMENTS

19220 YOUTH DR. BROOKSVILLE, FLORIDA 34601

ISSUE RECORD:



(C) THESE DRAWINGS & THEIR CONTENTS ARE THE SOLE PROPERTY OF PBA DESIGN GROUP, INC.
USE OR COPY OF ALL OR ANY PORTIONS IS BY CONTRACT ONLY. UNAUTHORIZED USE WILL BE PROSECUTED.
PBA DESIGN GROUP, INC.

No.	Description	Date

SHEET NO.

A0.0

Date MARCH 29, 2024

COVER SHEET

Scale: AS NOTED